




LOT 3
D.P. 404306
AREA 1.3012 ha

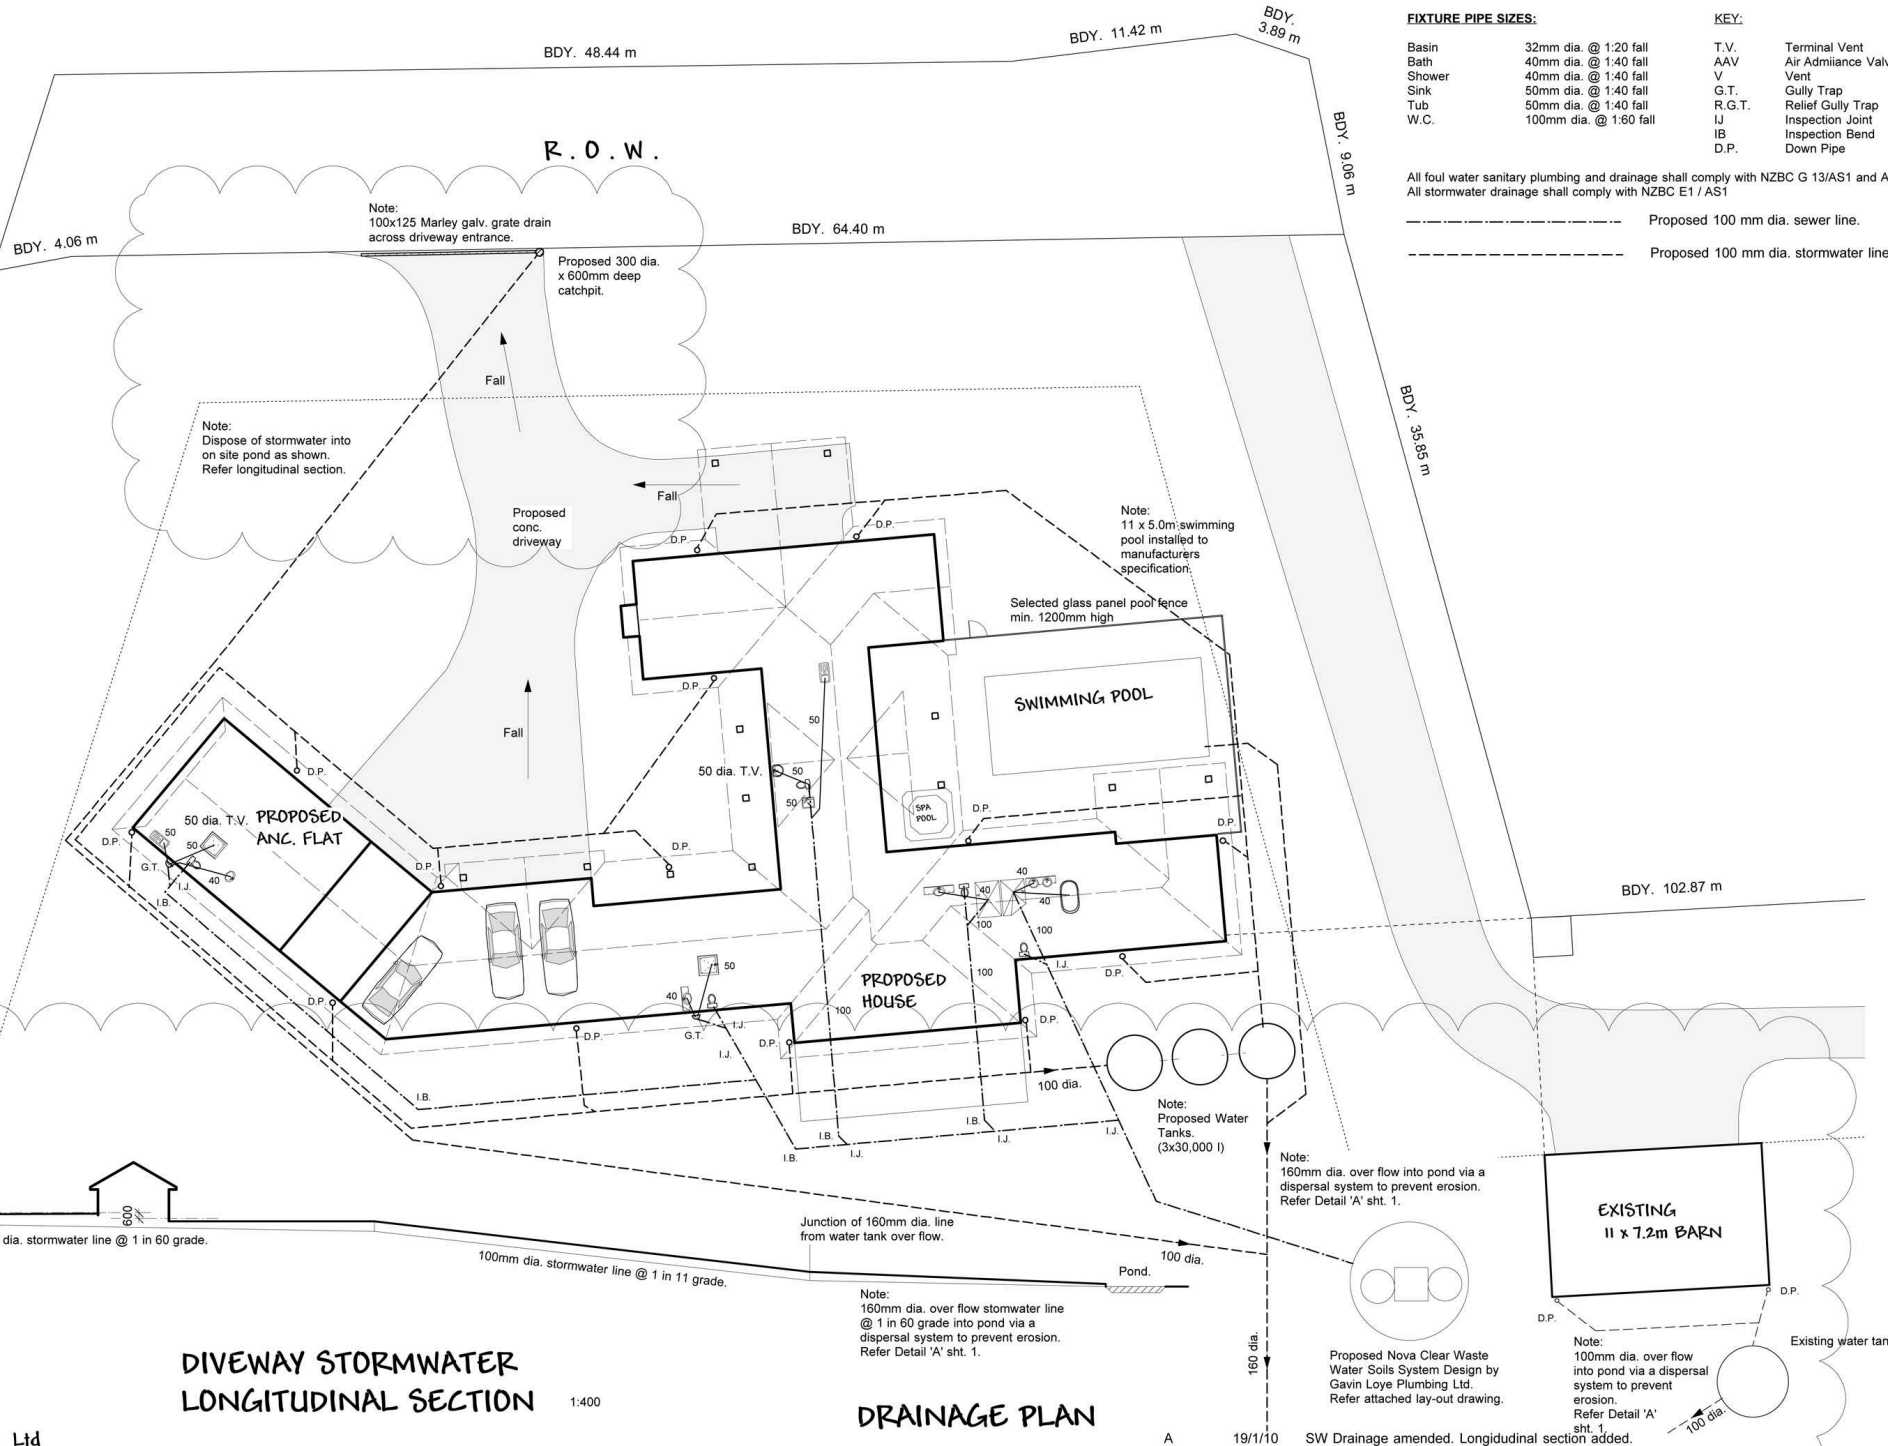

FIXTURE PIPE SIZES:

Basin	32mm dia. @ 1:20 fall	T.V.	Terminal Vent
Bath	40mm dia. @ 1:40 fall	AAV	Air Admittance Valve
Shower	40mm dia. @ 1:40 fall	V	Vent
Sink	50mm dia. @ 1:40 fall	G.T.	Gully Trap
Tub	50mm dia. @ 1:40 fall	R.G.T.	Relief Gully Trap
W.C.	100mm dia. @ 1:60 fall	I.J.	Inspection Joint
		IB	Inspection Bend
		D.P.	Down Pipe

KEY:

----- Proposed 100 mm dia. sewer line.
----- Proposed 100 mm dia. stormwater line.

All foul water sanitary plumbing and drainage shall comply with NZBC G 13/AS1 and AS2.
All stormwater drainage shall comply with NZBC E1 / AS1

DIVEWAY STORMWATER LONGITUDINAL SECTION 1:400
DRAINAGE PLAN

**PROPOSED RESIDENCE FOR PACIFIC HORIZON TRUST
AT 99B Highbrook Way SH 23**

Don Cowie Draughting & Design Services Ltd
N.Z.C.E.
20 Waimarie Street - Hamilton
Ph. 07 847 8864 Mobile 027 6041 392
Email: dcowie_design@hotmail.com

REVISION:	DATE:	REVISION NOTE:		
A	19/1/10	SW Drainage amended. Longitudinal section added.		
DRAINAGE PLAN			DRAWN	CHECKED
			D. Cowie / S. Fowler	D. Cowie
			DATE	SCALE
			Dec. 2009	1:200 @ A2
			JOB No.	
			914	
			OF	9

DWG No. **2** A REV